

ADT Fire & Security Ltd  
 11000 15th Avenue SW  
 Edmonton, Alberta T6A 4S2  
 Canada  
 Tel: 780-443-2222  
 Fax: 780-443-2223  
 www.adt.com

THE COPYRIGHT OF THIS DOCUMENT IS VESTED SOLELY IN ADT FIRE & SECURITY LTD.  
 REPRODUCTION OF THIS DOCUMENT IN WHOLE OR IN PART IS PROHIBITED OTHER THAN WITH THE EXPRESS PERMISSION OF THE ABOVE COMPANY.

ADT DNG NO:	0200
SET NO:	B
TYPE:	162
DWG NO:	A
REV:	02

**tyco** Fire & Security  
**ADT** Alarm, Therms & Security

**ADT** Fire & Security Ltd  
 11000 15th Avenue SW  
 Edmonton, Alberta T6A 4S2  
 Canada  
 Tel: 780-443-2222  
 Fax: 780-443-2223  
 www.adt.com

**CLIENT:**  
 EPSOM COACHES GROUP  
 21 BLENNHEIM ROAD  
 EPSOM SURREY

**CLIENT ADDRESS:**  
 5491 RD-01

**CLIENT ORIGINAL REFERENCE LAYOUT DRAWING:**  
 5491 RD-01

**ADT SALESPERSON:**  
 MARK SMITH

**DRAWING TITLE:**  
 FIRE ALARM LAYOUT  
 VEHICLE WASH PLANT ROOM STORE  
 AND DEPARTURE LOUNGE

**DRAWING STATUS:**  
 APPROVED

**CLIENT:**  
 EPSOM COACHES

**KEY PLAN:**

**REVISION HISTORY:**


NO.	DESCRIPTION	DATE	BY
1	ISSUED FOR PERIODIC REVIEW	07/05/09	ADT
2	ISSUED FOR PERIODIC REVIEW	07/05/09	ADT
3	ISSUED FOR PERIODIC REVIEW	07/05/09	ADT

**LEGEND:**

☉	MULTI BEACON HEAT AND SMOKE DETECTOR (MHS)
☉	LOOP POWERED SOLID STATE BLADE (LPSB)
☉	HEAT DETECTOR (HSD)
☉	DUCT PNEUM DETECTOR
☉	CALL POINT (CP)
☉	RELAY INTERFACE MODULE (RIM)
☉	DETECTION INTERFACE MODULE (DIM)
☉	SMOKEWELL / BEACON
☉	DECELS RELAYS
☉	WIRING ROUTES PPS00 1 & 2 CONE

**NOTES:**

- DO NOT SCALE FROM THIS DRAWING.
- ALL DIMENSIONS IN MILLIMETERS EXCEPT AS STATED OTHERWISE.
- THE WORK SHALL BE IN ACCORDANCE WITH ALL APPLICABLE STANDARDS AND REGULATIONS.
- THE DRAWING IS TO BE READ IN CONJUNCTION WITH ALL RELEVANT DOCUMENTS AND DRAWINGS.
- THE DRAWING IS TO BE READ IN CONJUNCTION WITH ALL RELEVANT DOCUMENTS AND DRAWINGS.
- ALL DIMENSIONS ARE TO BE AS SHOWN UNLESS OTHERWISE STATED. ALL DIMENSIONS ARE TO BE AS SHOWN UNLESS OTHERWISE STATED.
- ALL DIMENSIONS ARE TO BE AS SHOWN UNLESS OTHERWISE STATED.
- ALL DIMENSIONS ARE TO BE AS SHOWN UNLESS OTHERWISE STATED.

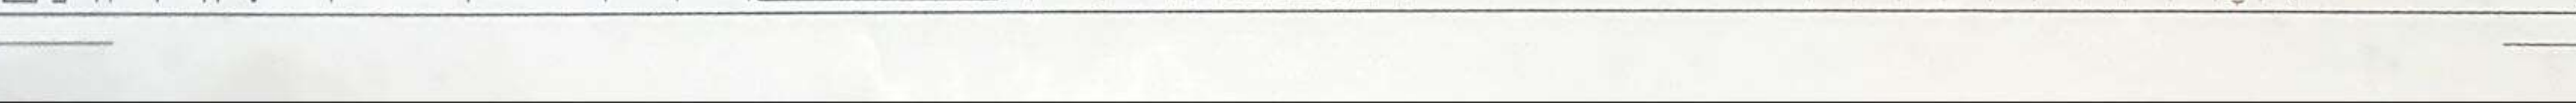

OUTLINE OF CANOPY

ZONE 08

VEHICLE WASH

DEPARTURE LOUNGE

ZONE 07

VEHICLE WASH PLANT ROOM

CLEANERS ROOM STORE

GENERATOR

OUTLINE OF CANOPY

ZONE 07

OUTLINE OF CANOPY

OUTLINE OF CANOPY

